


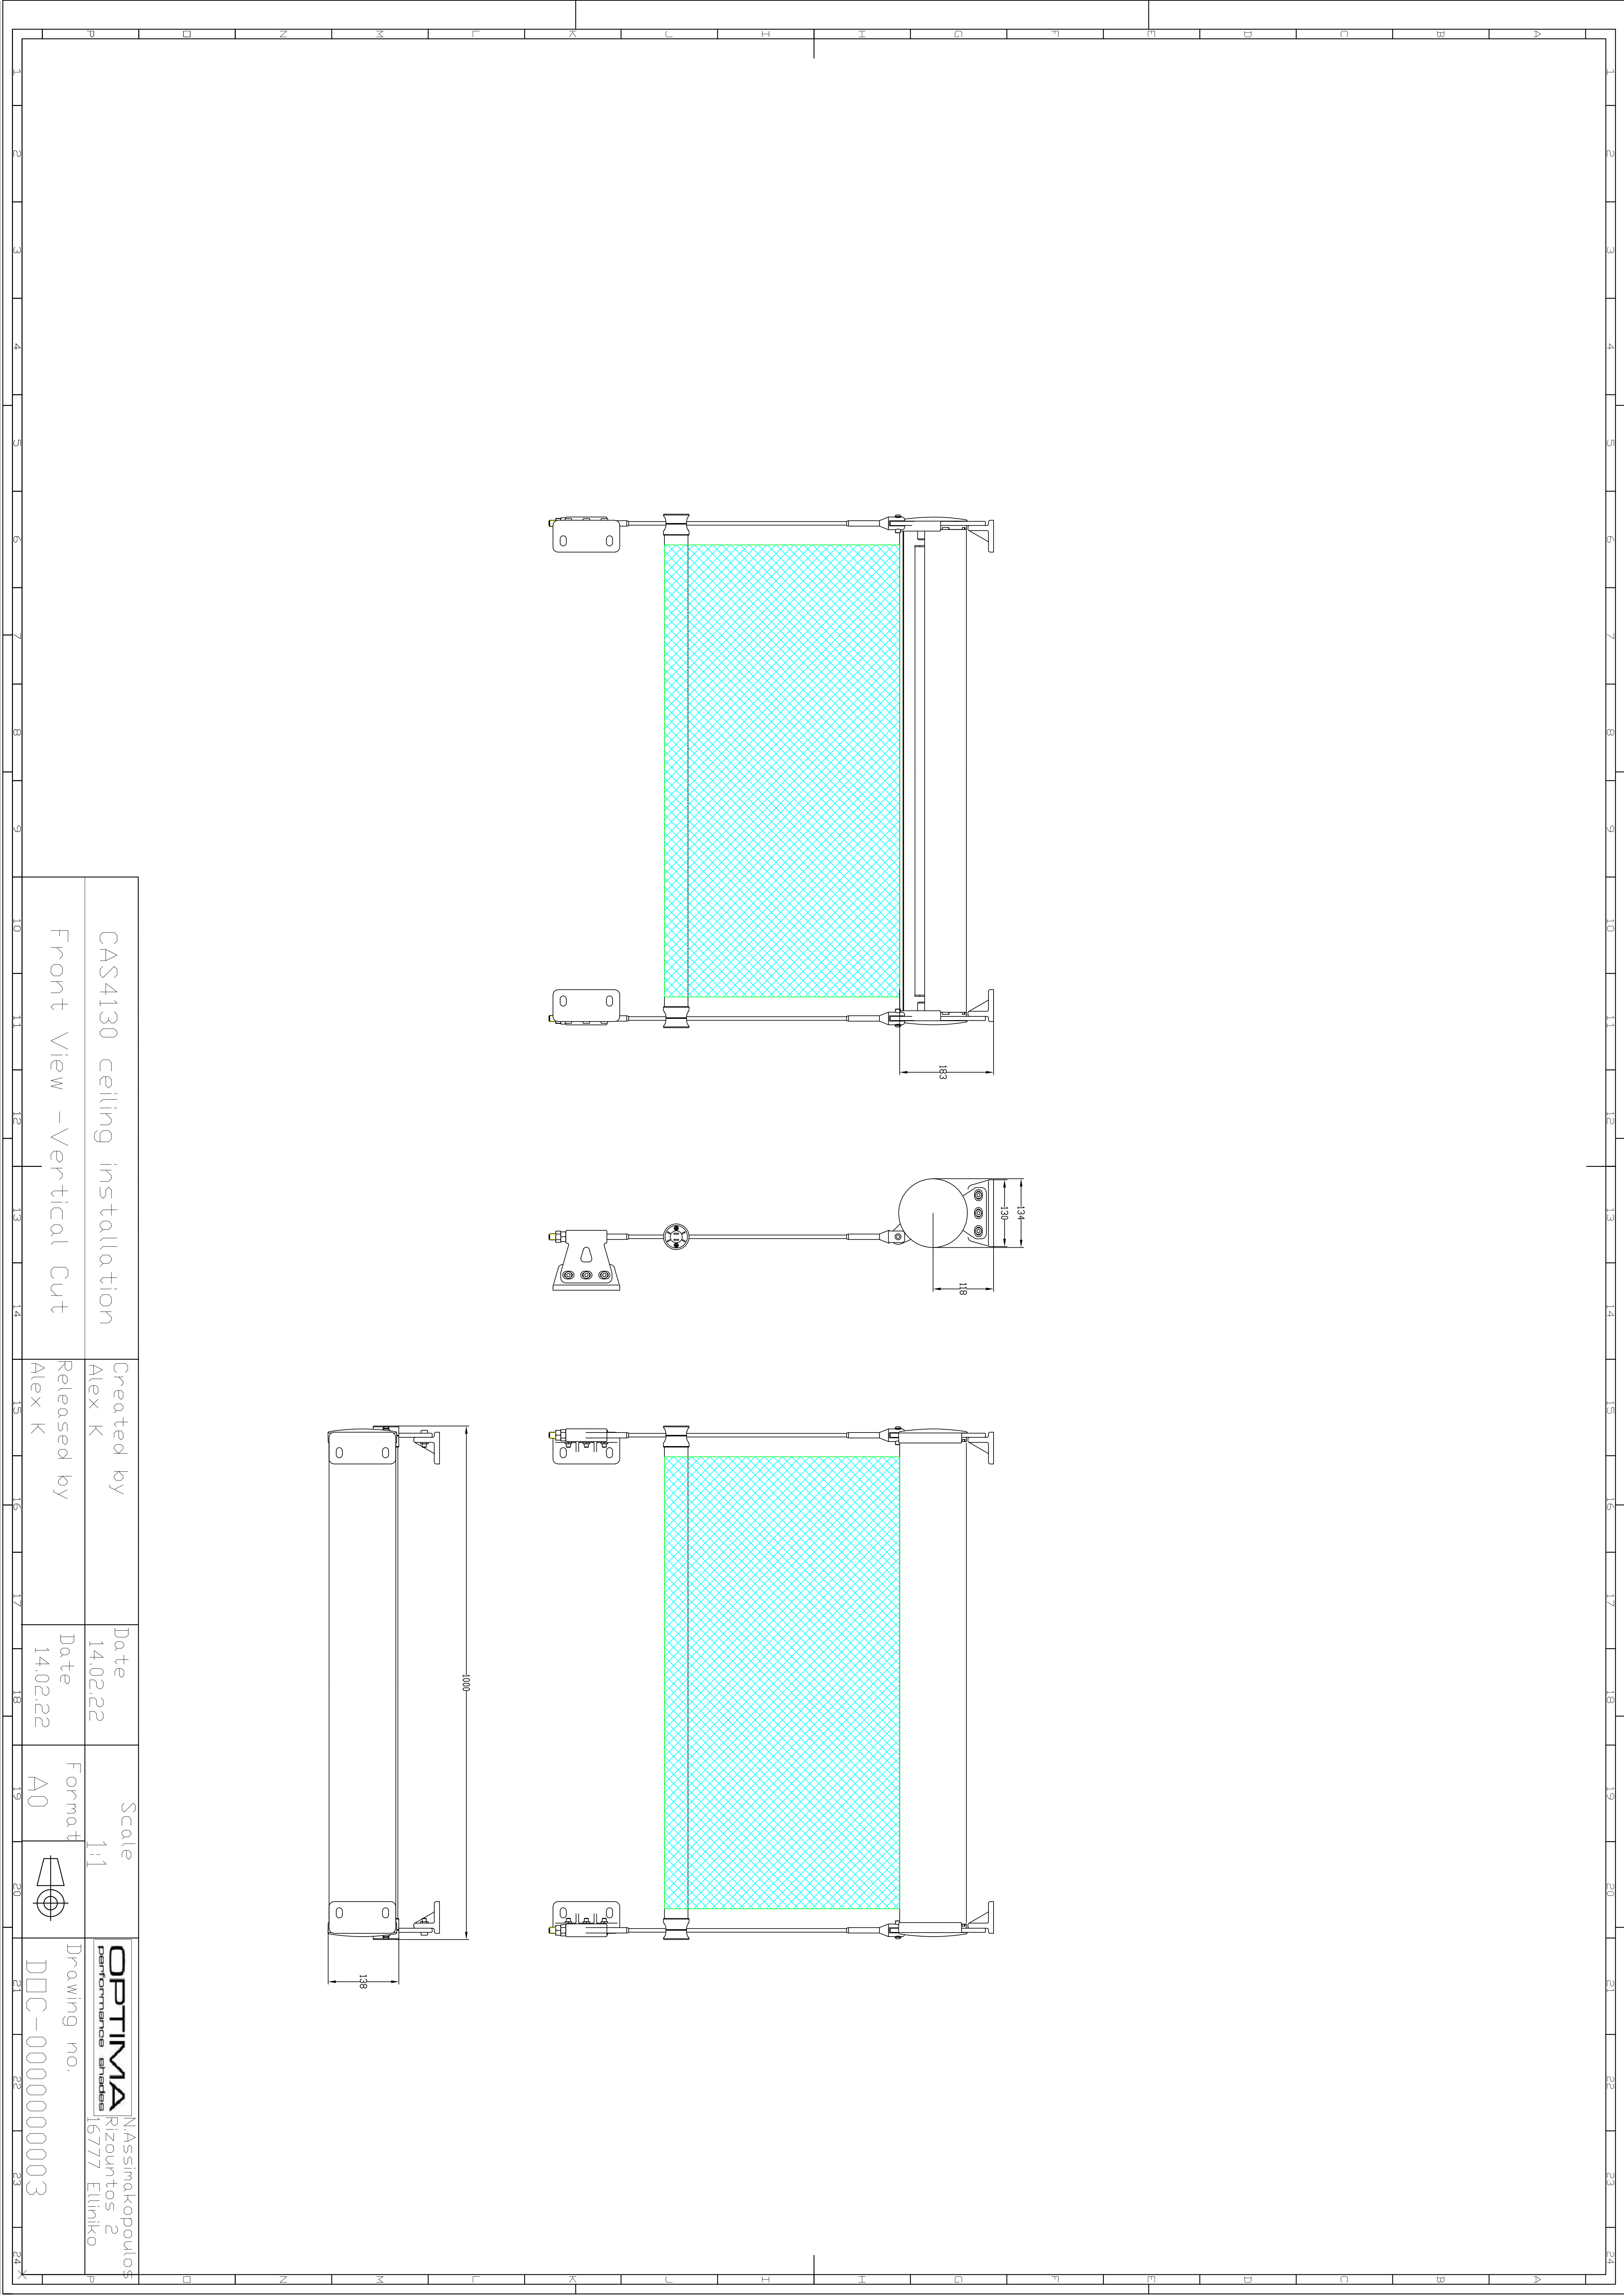

CAS4130 ceiling installation	Created by Alex K	Date 14.02.22	Scale 1:1	OPTIMA Nassimokopoulos Performance shades 16777 Elliniko
Front View - Vertical Cut	Released by Alex K	Date 14.02.22	Format A0	Drawing no. DDC-0000000003